


NOTES:
 1) ALL RAINWATER SIZED ON
 A) 2021 IPC TABLE 1106.2 w/
 2) 3"6" RAINFALL PER HOUR.
 2) ALL RAINWATER PIPING TO
 SLOPE AT 1/8" PER FOOT.
 3) PLUMBING CONTRACTOR TO
 PROVIDE HEAT TAPE ON ALL
 ROOF DRAIN & OVERFLOW
 DRAINS—SEE ELECTRICAL
 DRAWINGS & PLUMBING
 FIXTURE SCHEDULE.

6" RD & RDL
 6" OF & OFL
 5085 SQ. FT.
 317 GPM

6" RD & RDL
 6" OF & OFL
 3003 SQ. FT.
 187 GPM

RDL/OFL OF SIZE SHOWN TO DROP DOWN
 INSIDE FACE OF WALL. RDL AND OFL TO
 DISCHARGE AT FACE OF BUILDING TO SPILLWAY
 AT 6" ABOVE FINISHED GRADE (VERIFY W/ARCH)

6" RD & RDL
 6" OF & OFL
 4470 SQ. FT.
 187 GPM

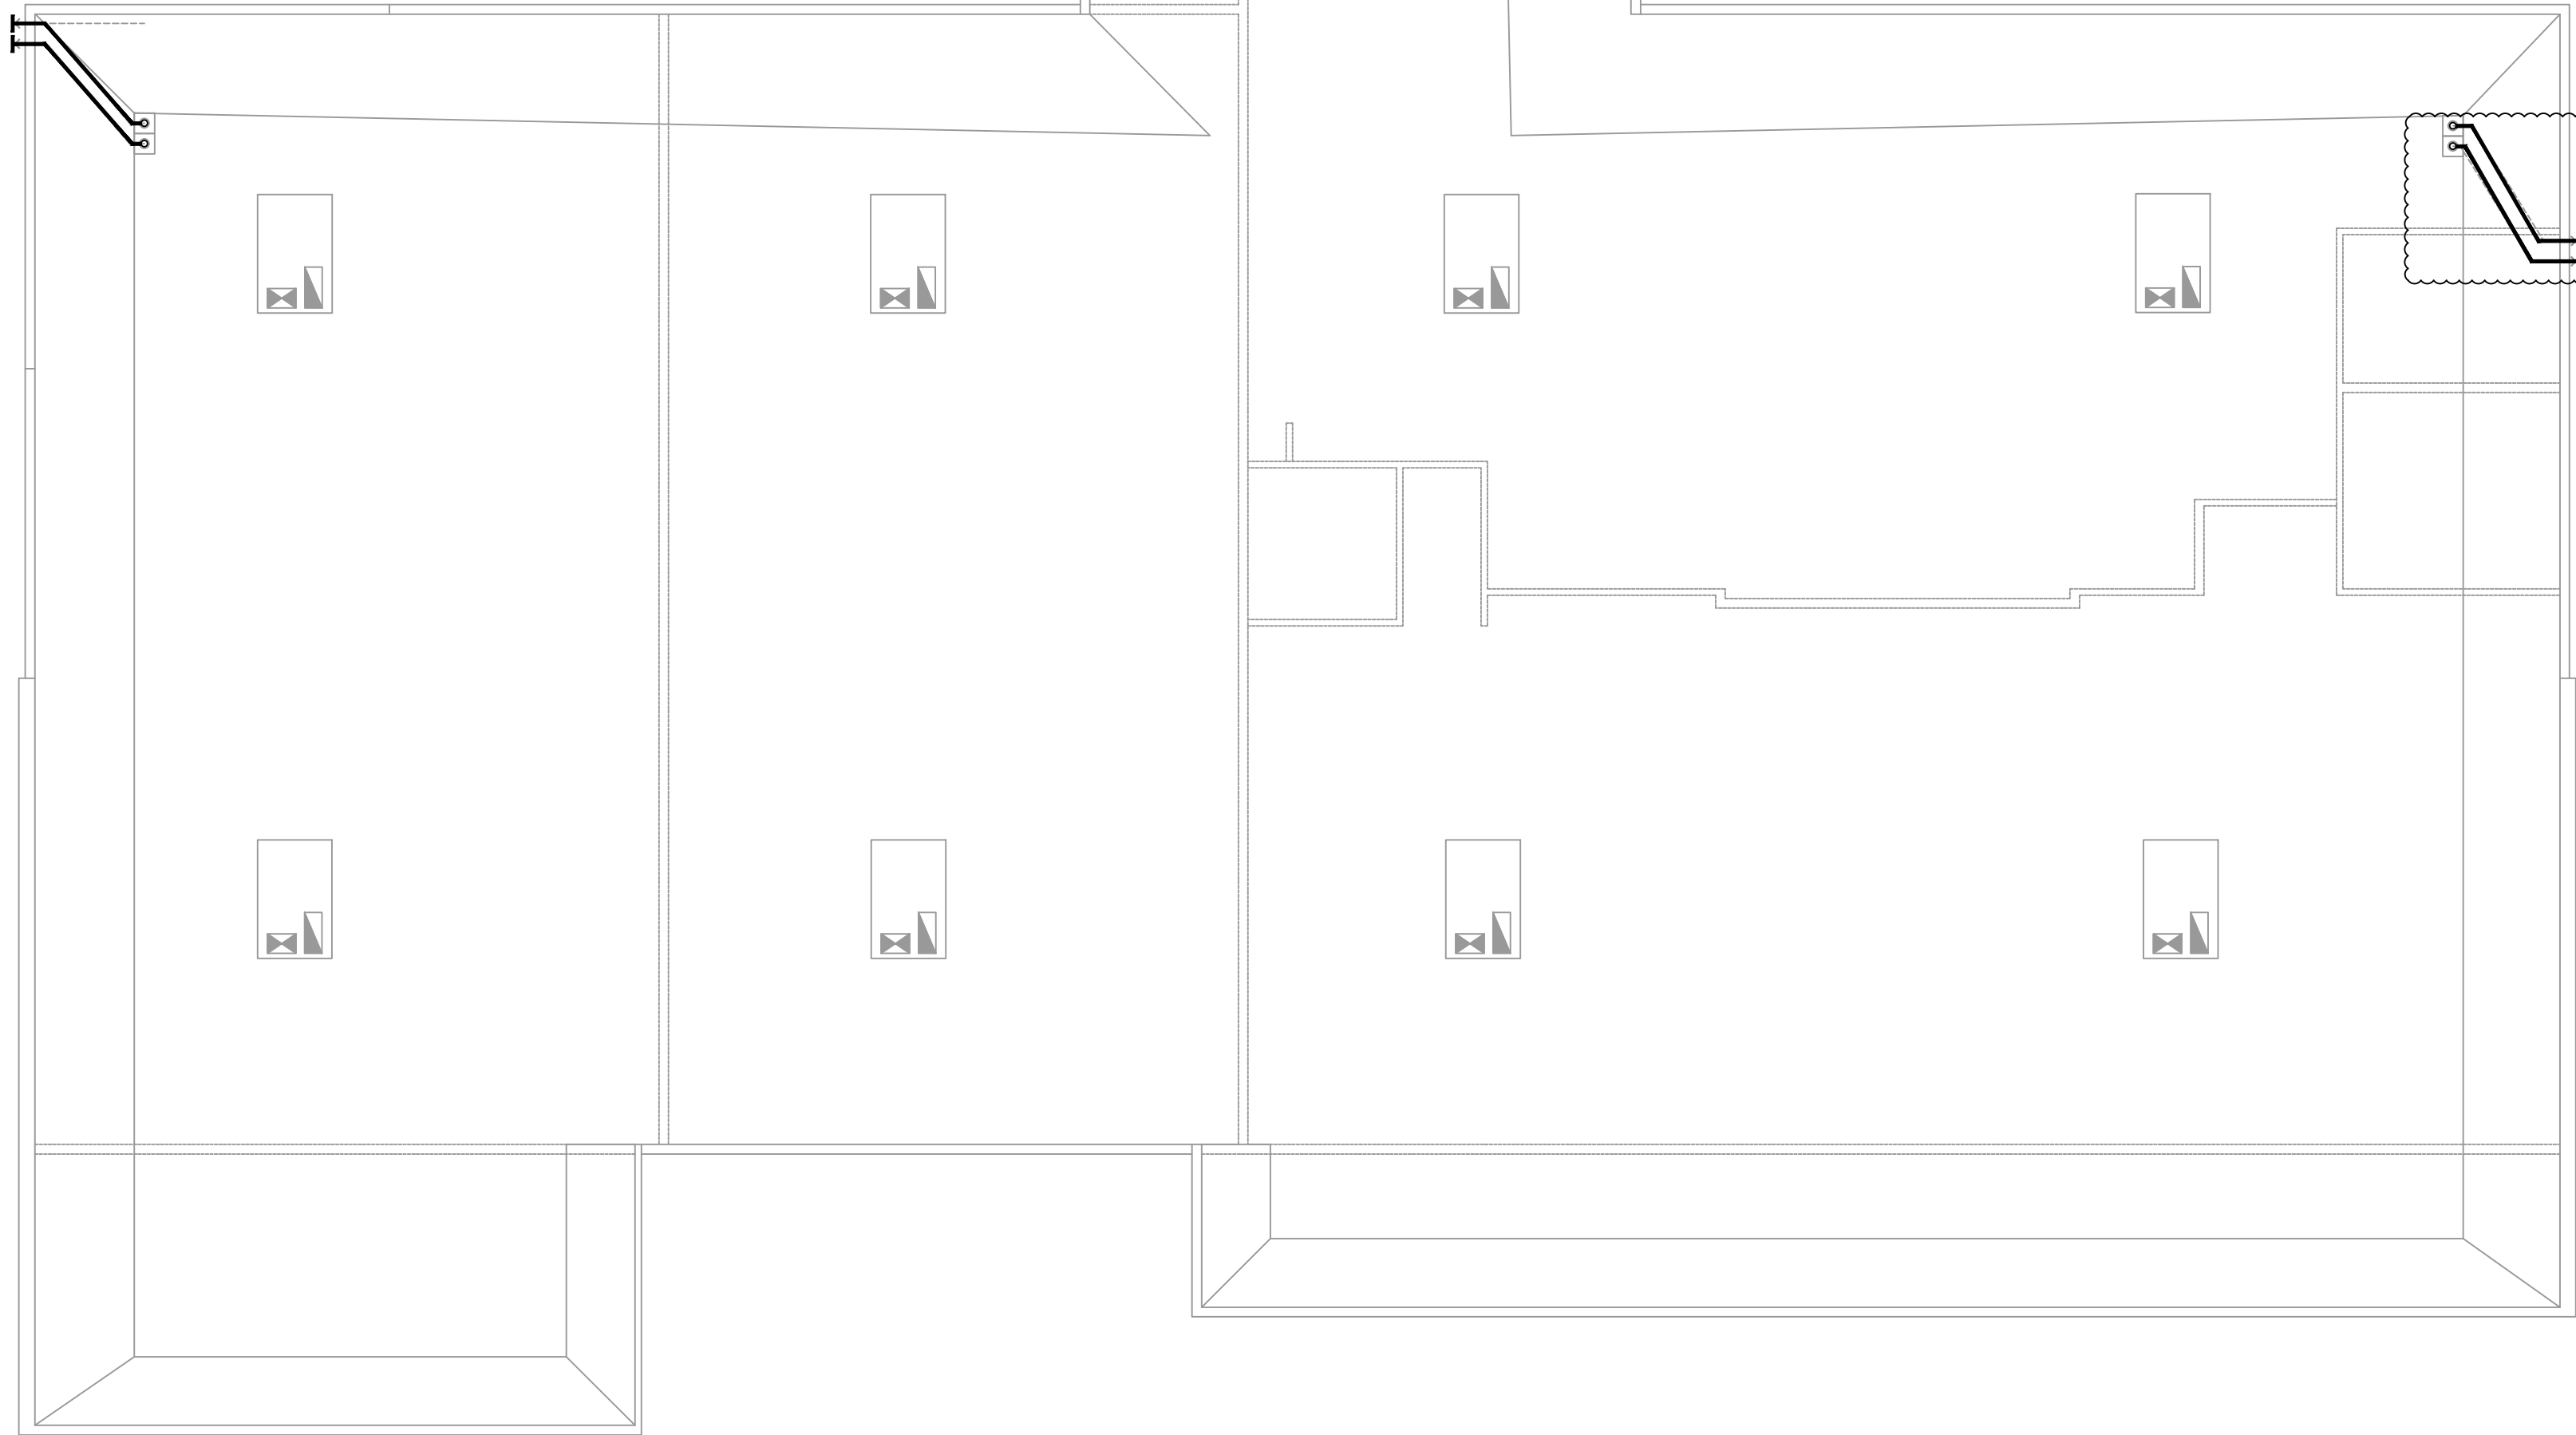

PLUMBING ROOF PLAN
 1/8"=1'-0" NORTH



RK
 ARCHITECTS
 2333 EAST THOMAS ROAD, PHOENIX, ARIZONA 85016
 602-955-3900
 RICA.COM



DATE : 08-22-24

DATE	OWNER CHANGES	CITY COMMENTS
08-22-24		
09-18-24		

NOTICE OF ALTERNATE BILLING OR PAYMENT CYCLE:
 THIS CONTRACT MAY ALLOW THE OWNER TO REQUIRE
 THE COMPLETION OF BILLING OR ESTIMATES IN
 BILLING CYCLES OTHER THAN THIRTY DAYS. THIS
 CONTRACT MAY ALLOW OWNER TO MAKE PAYMENT
 CERTIFICATION AND APPROVAL OF BILLING AND
 ESTIMATES. A WRITTEN DESCRIPTION OF SUCH CYCLE
 BILLING CYCLE APPLICABLE TO THE PROJECT IS
 AVAILABLE FROM OWNER OR DESIGNATED AGENT.
 BILL
 ADDRESS
 CONTACT: Name
 PHONE

NEW COMMERCIAL PAD
 PAD 5B AT PASEO LINDO SHOPPING CENTER
 NEC OF ARIZONA AVE AND OCOTILLO RD.
 CHANDLER, AZ

CONSTRUCTION SET_11-12-24

COPYRIGHT 2024, ALL RIGHTS RESERVED. THIS
 DRAWING IS AN INSTRUMENT OF SERVICE. IT IS THE
 PROPERTY OF RK ARCHITECTS, INC. AND MAY NOT BE
 REPRODUCED OR REPRODUCED IN ANY MANNER
 WITHOUT WRITTEN PERMISSION OF THE
 CORPORATION.

design by: **WF**
 drawn by: **WF**
 checked by: **JG**

7227 N. 16th Street, Suite 200, Phoenix, AZ 85020
 Job No: 20225
Consulting Engineers
 Phone (602) 943-6008
 Fax (602) 943-6181
 Web: MechDesigns.com

P101
 project #: 23057